







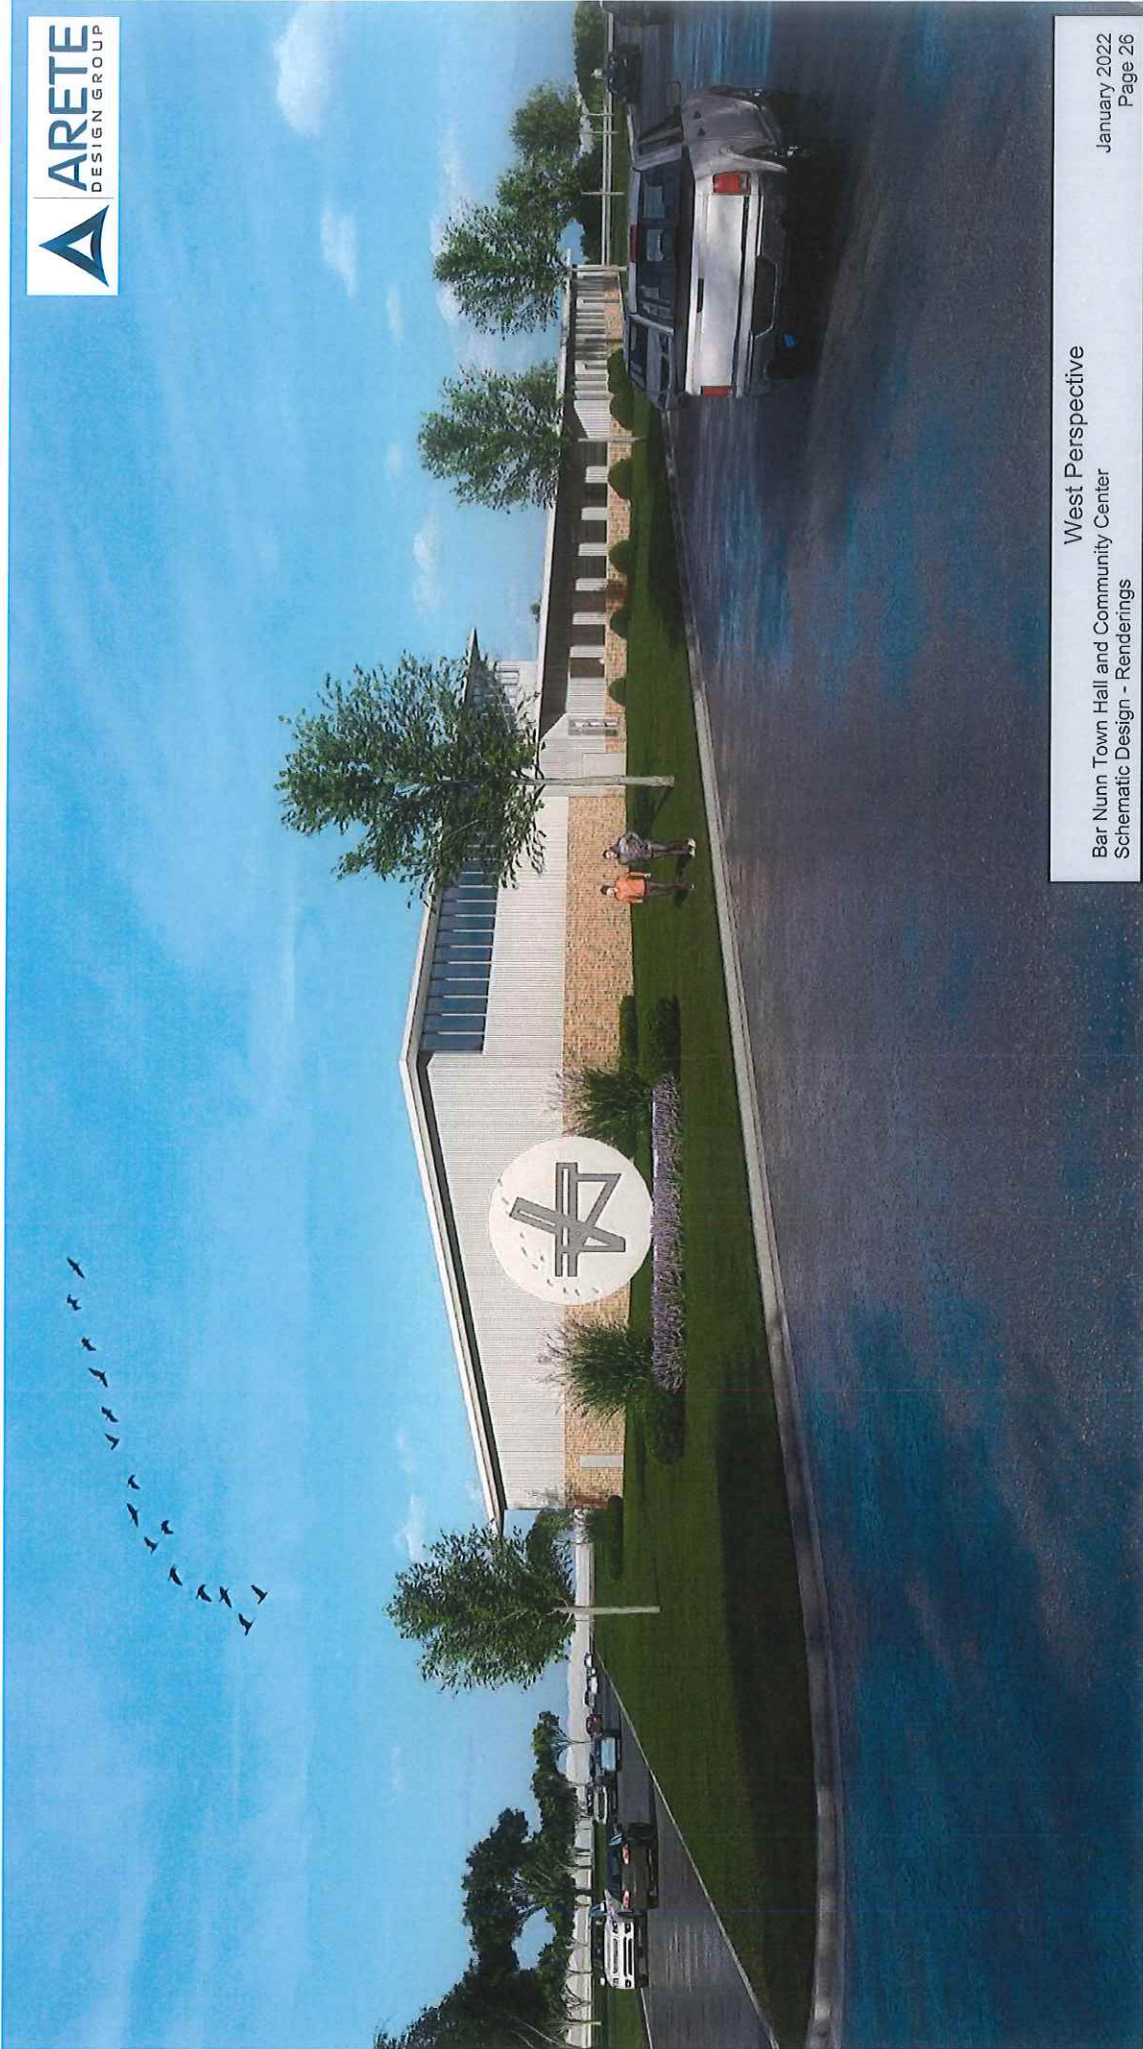

NAME: ENGINEER	NAME: ARCHITECT
CONTACT: ARCHITECT	CONTACT: ARCHITECT
ADDRESS: 1	ADDRESS: 1
PHONE: 1	PHONE: 1
EMAIL: 1	EMAIL: 1
NAME: STRUCTURAL ENGINEER	NAME: MECHANICAL ENGINEER
CONTACT: STRUCTURAL ENGINEER	CONTACT: MECHANICAL ENGINEER
ADDRESS: 2	ADDRESS: 2
PHONE: 2	PHONE: 2
EMAIL: 2	EMAIL: 2
NAME: MECHANICAL ENGINEER	NAME: ELECTRICAL ENGINEER
CONTACT: MECHANICAL ENGINEER	CONTACT: ELECTRICAL ENGINEER
ADDRESS: 3	ADDRESS: 3
PHONE: 3	PHONE: 3
EMAIL: 3	EMAIL: 3

BAR NUNN TOWN HALL

DATE: 01/11/2022	DATE: 01/11/2022
PROJECT NUMBER: 2022-038	PROJECT NUMBER: 2022-038
DESIGNER: ARETE DESIGN GROUP	DESIGNER: ARETE DESIGN GROUP

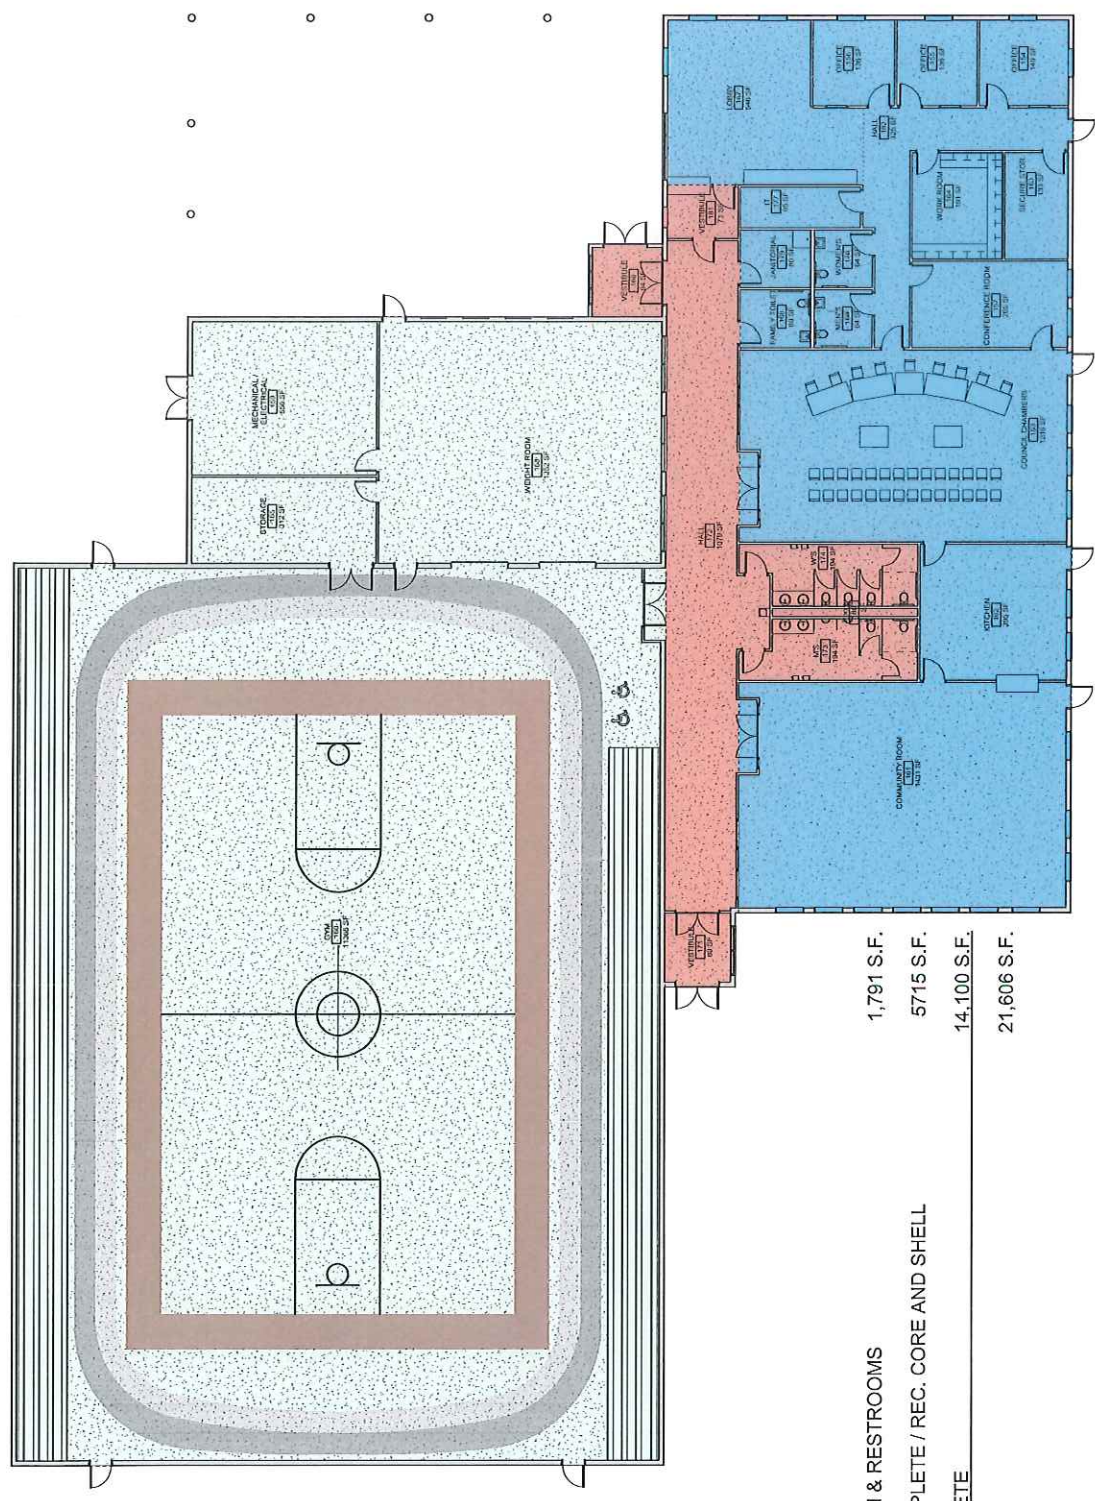

1,791 S.F.
5715 S.F.
14,100 S.F.
21,606 S.F.

CIRCULATION & RESTROOMS
OFFICE COMPLETE / REC. CORE AND SHELL
REC. COMPLETE
TOTAL:

1.1ST FLOOR PLAN - OPTION 2B - LARGE FLOOR PLAN
SCALE: 1/8" = 1'-0"